


NOTE:- 1- All dimension in millimeter unless otherwise specified.
 2- The contractor has to submit the coordinated shop drawing with other services before commencing of work and get approval of client.

Project - VRV/ VRF Air Contioning of SIDBI Tower , Lucknow

LEGEND FOR HVAC

S.NO.	SYMBOL	LAYERS NAME
1.		4 WAY CASSETTE
2.		1 WAY CASSETTE
4.		REFNET
5.		REFRIGERANT PIPE (COPPER) WITH 13/19 MM INSULATION
6.		DRAIN PIPE WITH 6 MM INSULATION
7.		ENERGY RECOVERY VENTILATOR (ERV)
8.		SUPPLY AIR DUCT (150MM)
9.		EXHAUST SIR DUCT (150MM)
10.		DISC VALVE
11.		EXHAUST/FRESH AIR LOUVER

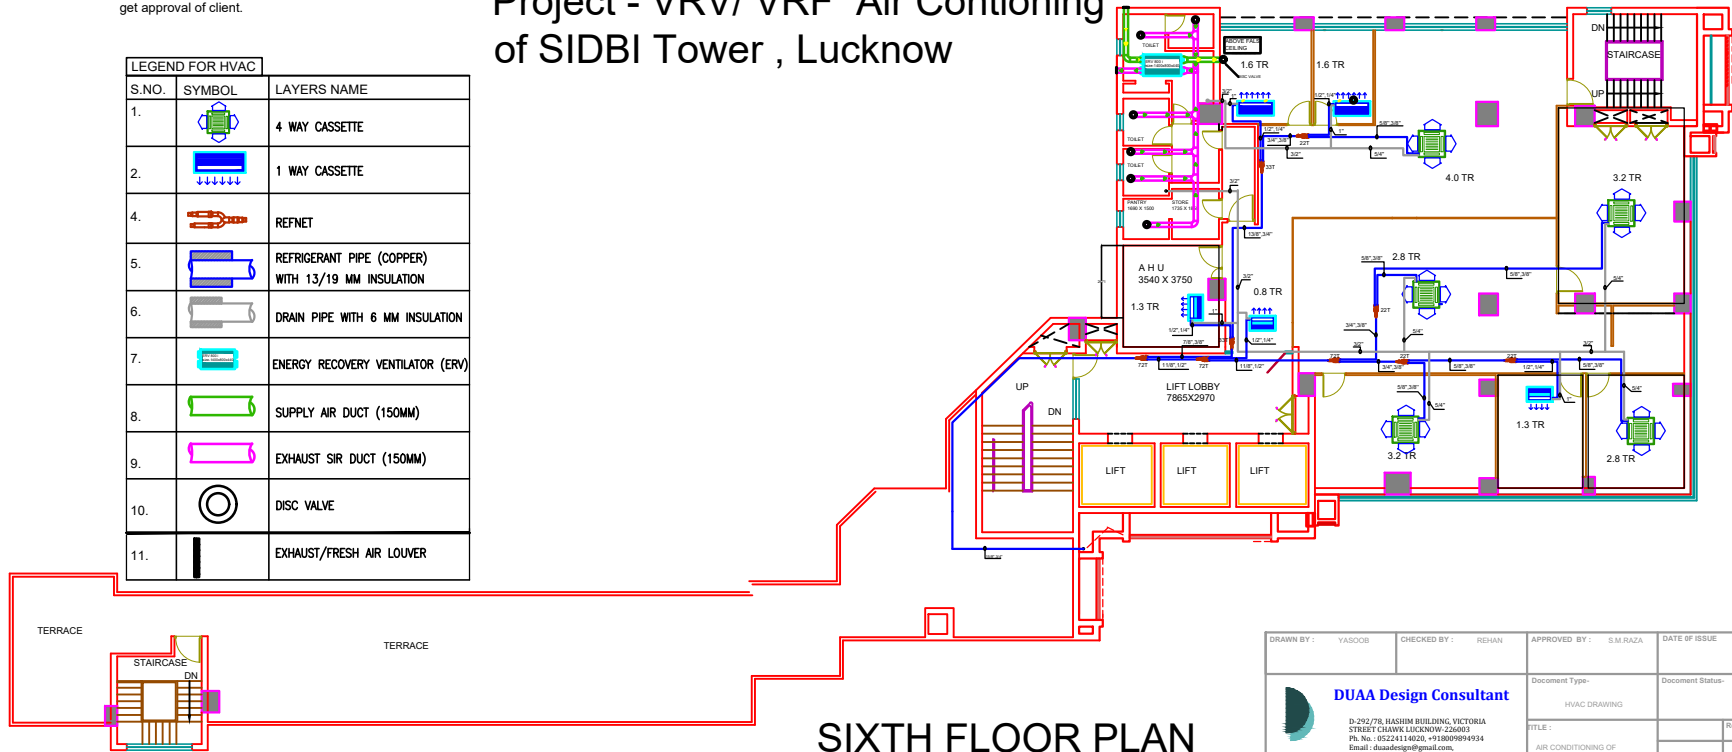

SIXTH FLOOR PLAN

DRAWN BY :- VASOOB	CHECKED BY :- RESHAN	APPROVED BY :- S.M.RAZA	DATE OF ISSUE :- 16.12.2019
DUA Design Consultant		Document Type:- HVAC DRAWING	Document Status:- TENDER
D-292/78, HASHIM BUILDING, VICTORIA STREET CHAWK, LUCKNOW-226003 Ph. No. - 05224114600, +91809984934 Email - duaadesign@gmail.com.			Rev:- 0
TITLE :- AIR CONDITIONING OF SIDBI TOWER, LUCKNOW			